




1 INTAKE PLAN  
SCALE: 1" = 10'

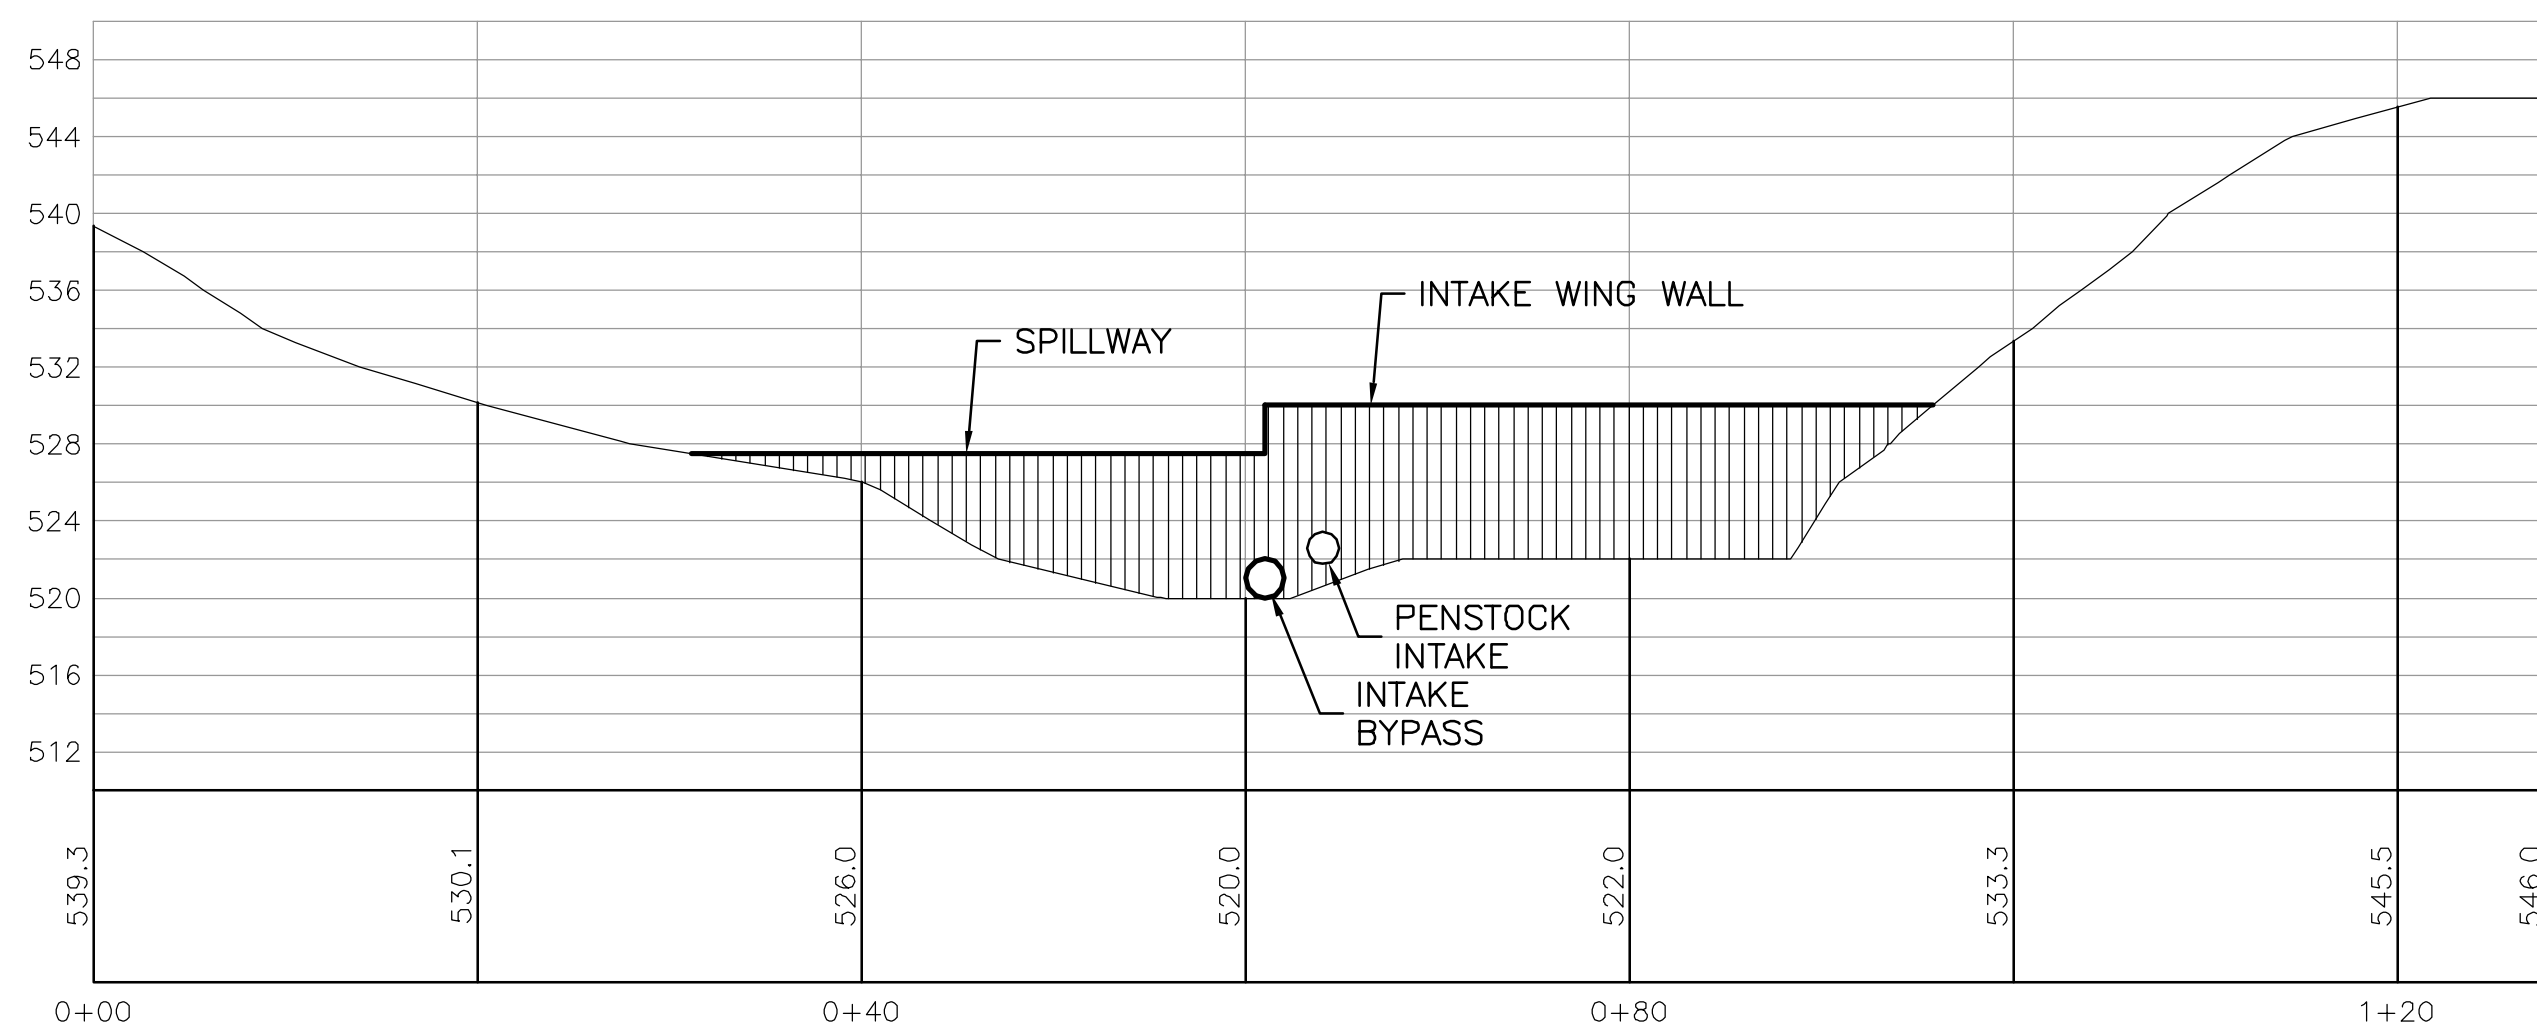

2 INTAKE ELEVATION  
SCALE: 1" = 10'

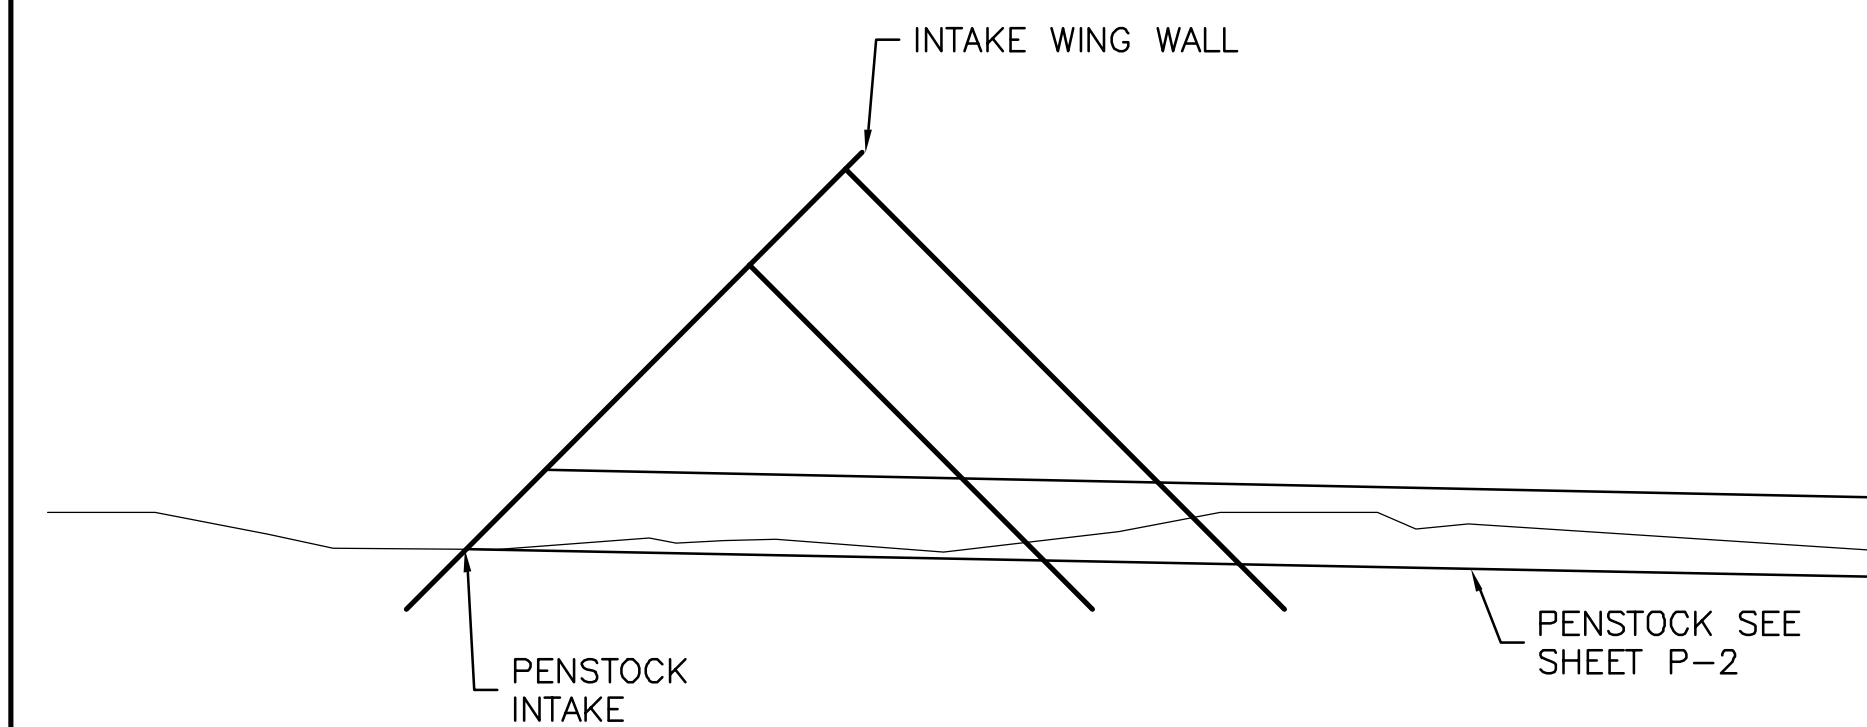

3 INTAKE SECTION  
SCALE: 1" = 4'

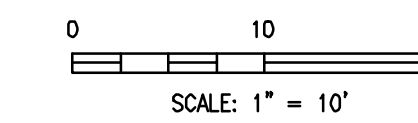

DRAFT  
 06/21/10

DAM PLAN AND PROFILE

Project  
 PACKERS CREEK HYDROELECTRIC PROJECT  
 CHIGNIK LAGOON POWER UTILITY  
 Chignik Lagoon, AK

DATE: 6/14/10  
 DESIGNED: MDD  
 DRAWN: MDD  
 CHECKED:  
 SCALE: AsNoted  
 FILE: PackersCrkHydro

Sheet  
**D-1**  
 OF

NOT FOR CONSTRUCTION

NO. DATE REVISIONS

**polarconsult alaska, inc.**  
 ENERGY SYSTEMS • ENVIRONMENTAL SERVICES • ENGINEERING DESIGN  
 15003 WEST 33RD AVE., SUITE 310    PHONE (907) 258-2420  
 ANCHORAGE, ALASKA 99503    FAX (907) 258-2419